


FRONT

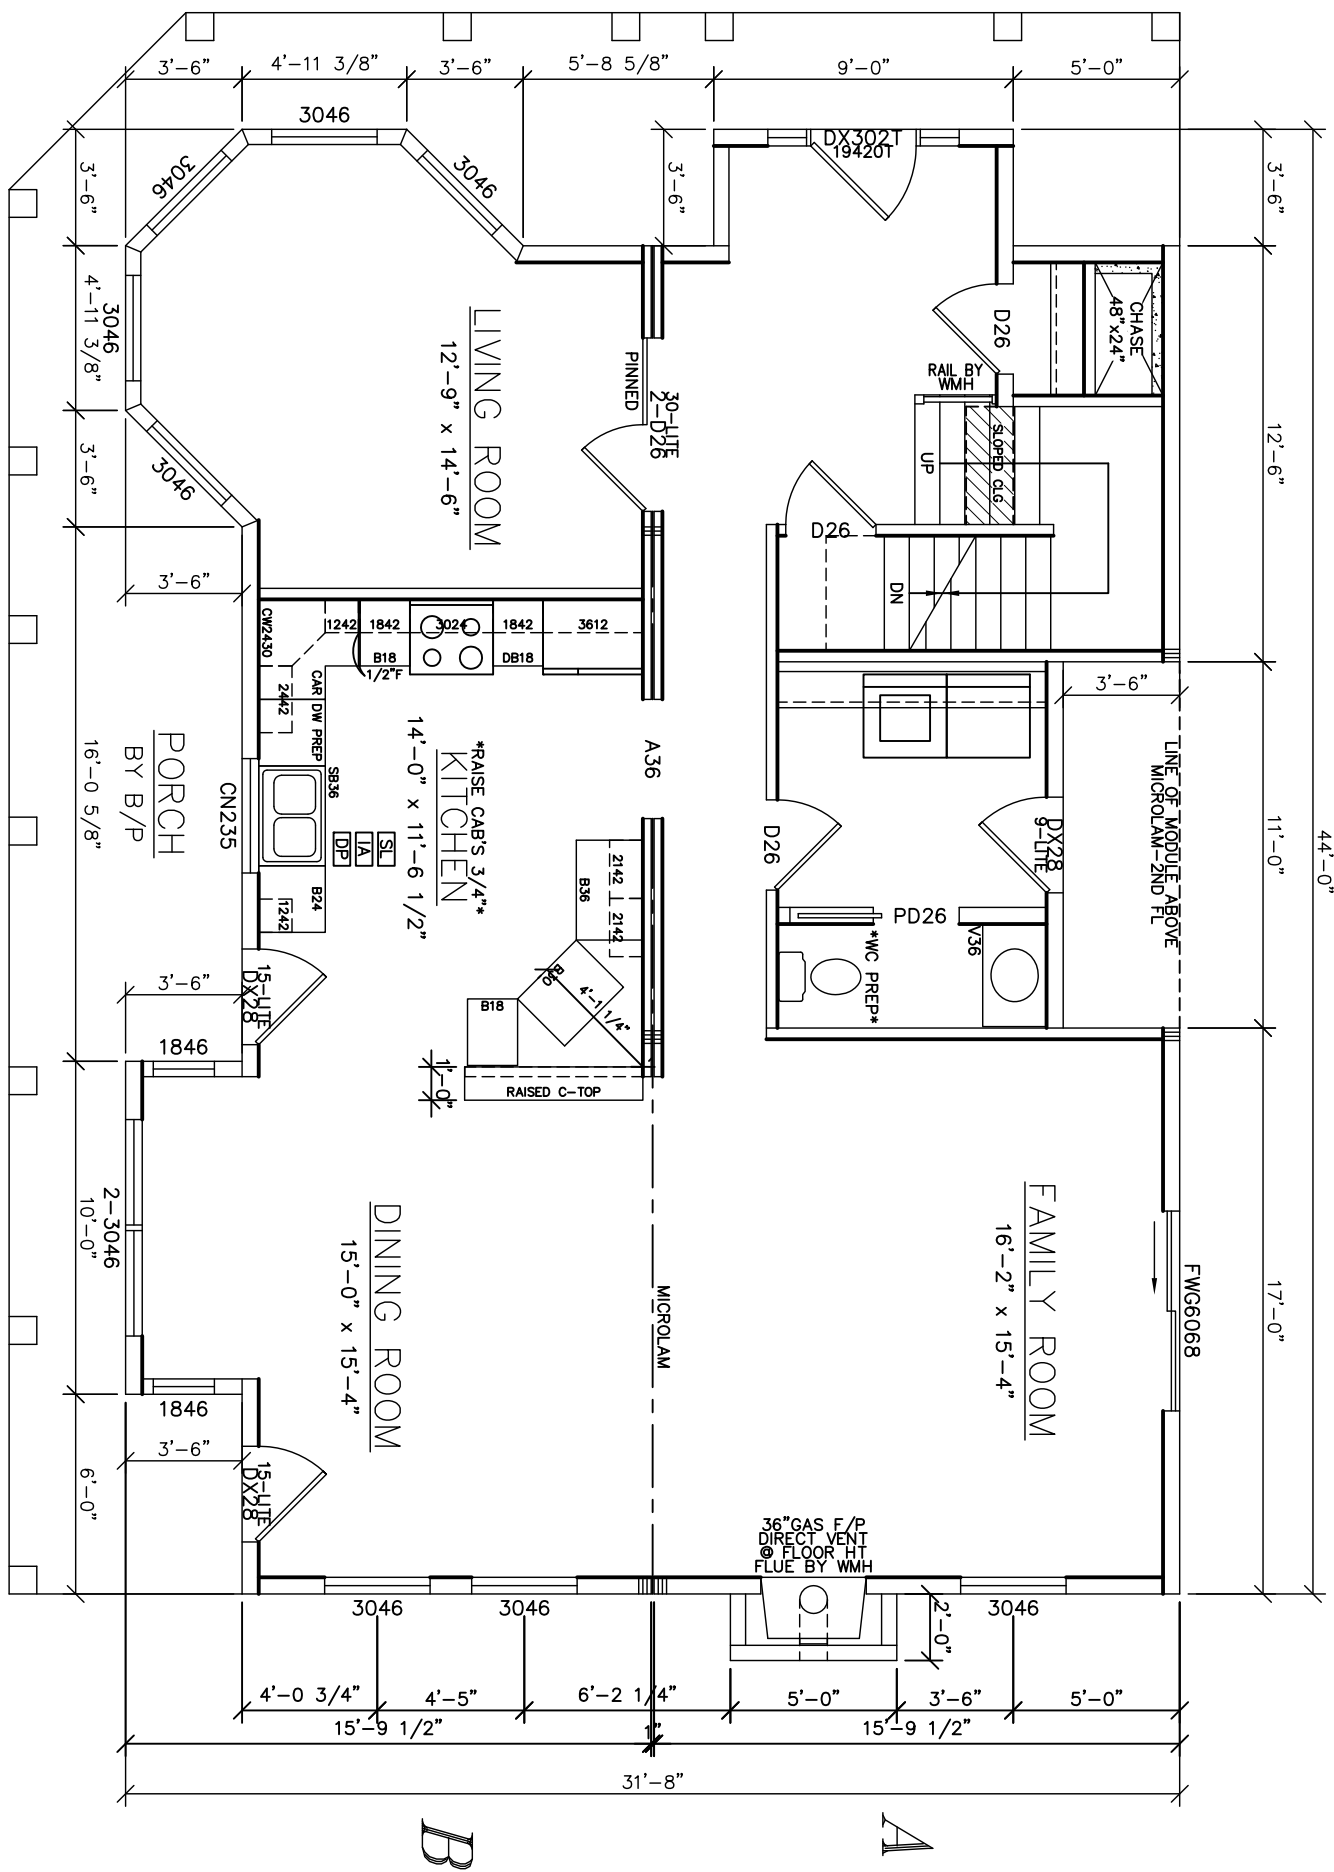

LIGHT & VENTILATION SCHEDULE (SF)

ROOM	AREA	LIGHT		VENT	
		REQUIRED	SUPPLIED	REQUIRED	SUPPLIED
LIVING ROOM	148	11.8	51.5	5.92	28.65
FAMILY ROOM	248	19.8	34.1	9.92	20.45
DINING ROOM	210	16.8	51.2	8.40	28.96
KITCHEN	162	12.9	8.0	6.48	7.20


COMBINED

ICYNEN INSULATION
 9'-0" CEILING HEIGHT
 ENTIRE 1ST FLOOR
 - 2 PANEL SOLID SMOOTH DOORS

SEE STANDARD NOTES & DETAILS DWG #8

USE GROUP: SINGLE FAMILY CONST. TYPE: 5B DESIGNER: V. GIORGIO DATE: 09/08/08 SCALE: 1/4" = 1'-0" PAGE: 3A	BUILDER: TRANSPARENTLY GREEN 4 HIDDEN MEADOW DRIVE WARWICK, NY 10990 HOMEOWNER: SPEC SITE: 28 HOYT ROAD WARWICK, NY 10990	SERIAL No. 08162 PRODUCTION No. REVISION DATE CHECK DATE	PE / RA	THIRD PARTY INSPECTION AGENCY
<h1 style="margin: 0;">COLONIAL CTM-R</h1> <h2 style="margin: 0;">FIRST FLOOR PLAN</h2>				
Westchester Modular Homes Inc 30 Reagans Mill Road, Wingdale, New York, 12594 Tel (845)832-9400 Fax (845)832-6698				

FRONT

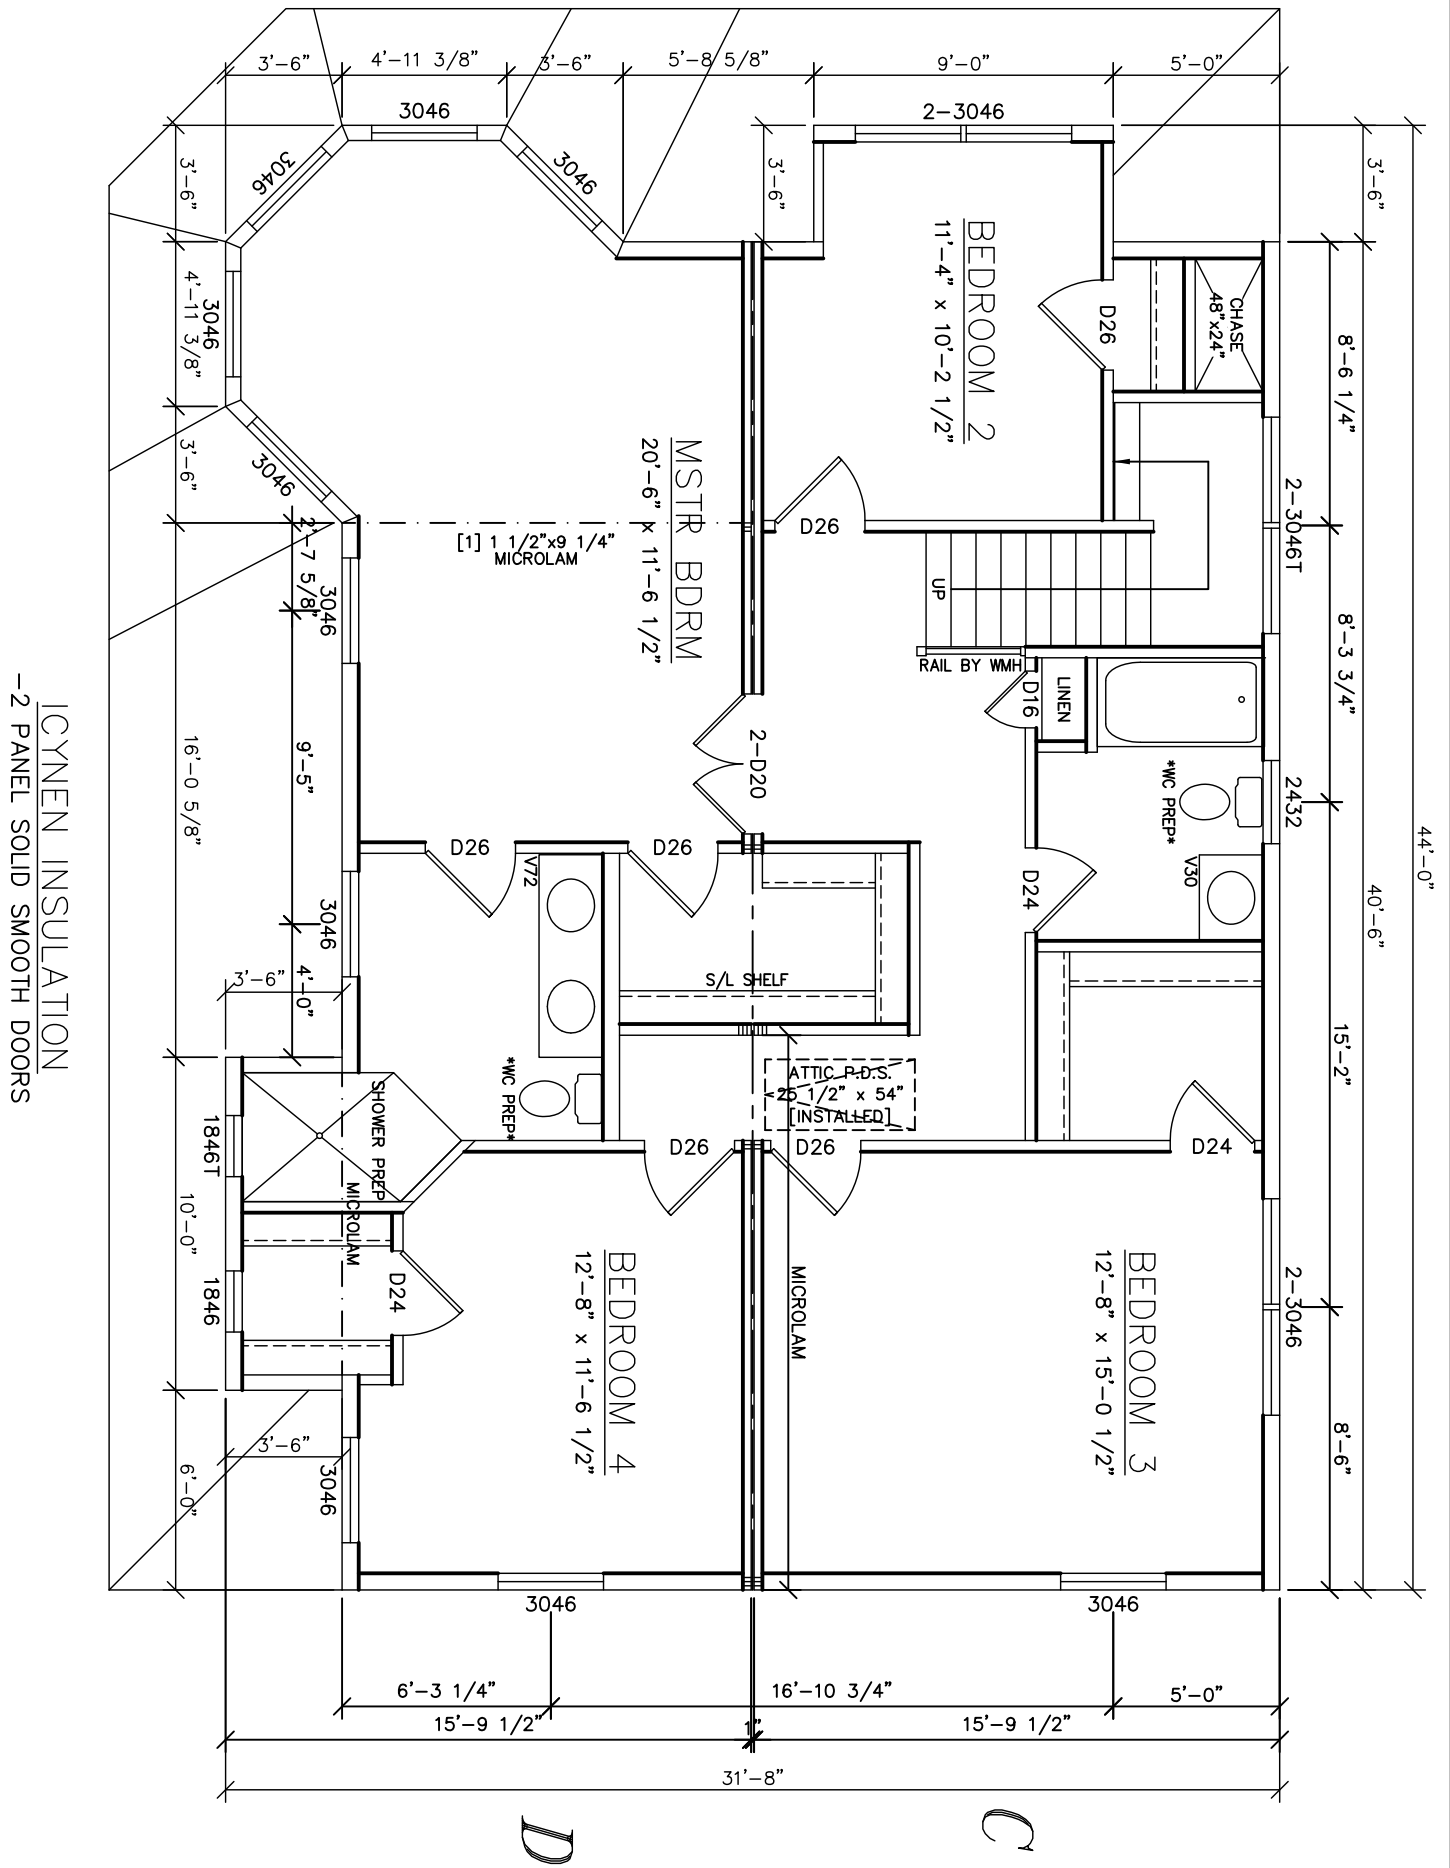


LIGHT & VENTILATION SCHEDULE (SF)

ROOM	AREA	LIGHT		VENT	
		REQUIRED	SUPPLIED	REQUIRED	SUPPLIED
MSTR BDRM	237	.	61.8	.	34.38
BEDROOM 2	112	.	20.6	.	11.46
BEDROOM 3	191	.	30.9	.	17.19
BEDROOM 4	146	.	20.6	.	11.46

ICYNEN INSULATION
- 2 PANEL SOLID SMOOTH DOORS


SEE STANDARD NOTES & DETAILS DWG #8

USE GROUP: SINGLE FAMILY CONST. TYPE: 5B DESIGNER: V. GIORGIO DATE: 09/08/08 SCALE: 1/4" = 1'-0" PAGE: 3B	BUILDER: TRANSPARENTLY GREEN 4 HIDDEN MEADOW DRIVE WARWICK, NY 10990	HOMEOWNER: SPEC SITE: 28 HOYT ROAD WARWICK, NY 10990	SERIAL No. 08162	PE / RA	THIRD PARTY INSPECTION AGENCY
			PRODUCTION No.		
COLONIAL CTM-R SECOND FLOOR PLAN			REVISION	DATE	
			CHECK	DATE	
Westchester Modular Homes Inc 30 Reagans Mill Road, Wingdale, New York, 12594 Tel (845)832-9400 Fax (845)832-6698					

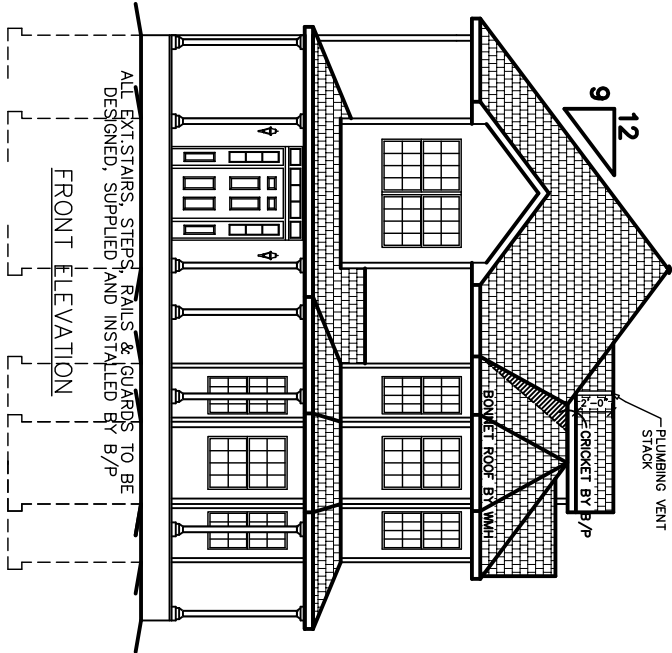

ALL EX-STAIRS, STEPS, RAILS & GUARDS TO BE DESIGNED, SUPPLIED AND INSTALLED BY B/P


FRONT ELEVATION

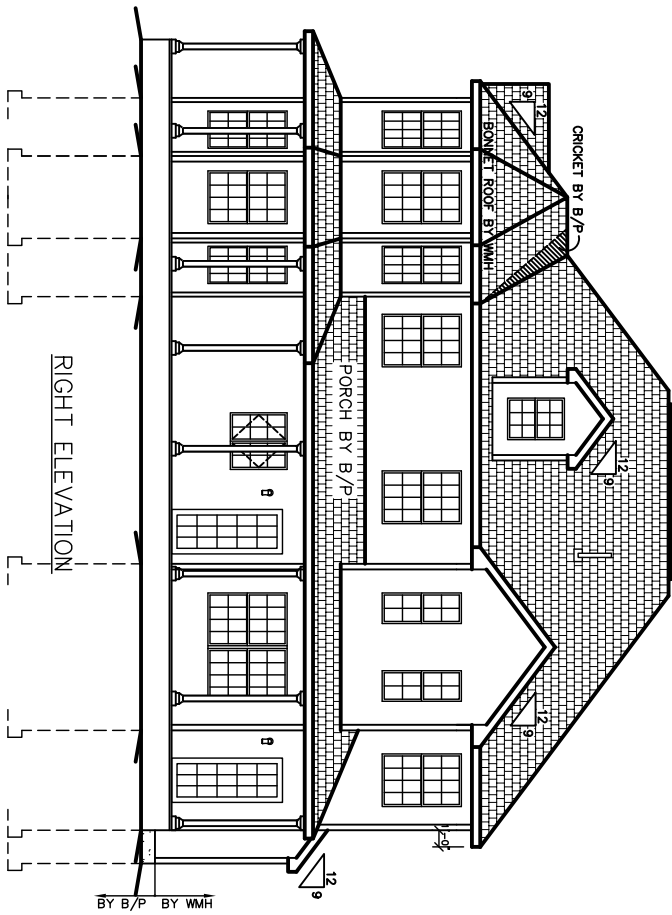


RIGHT ELEVATION

BY B/P BY WMH

SIDING BY B/P

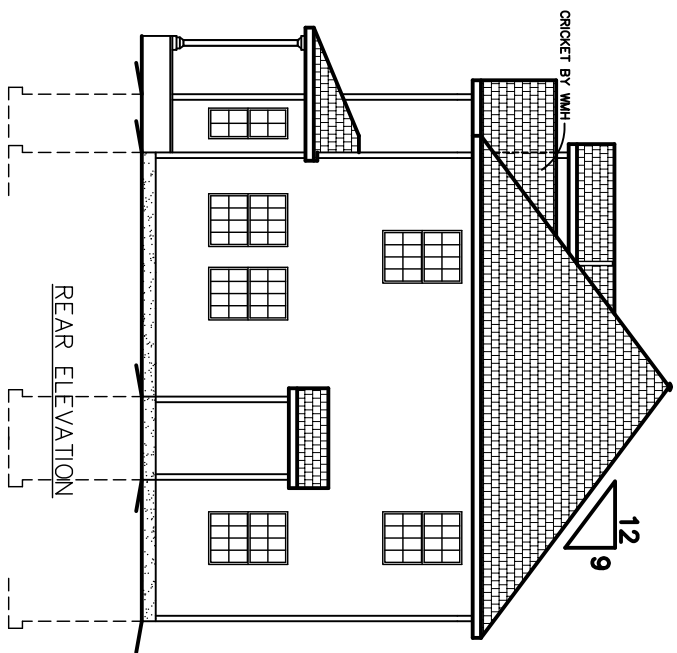


REAR ELEVATION

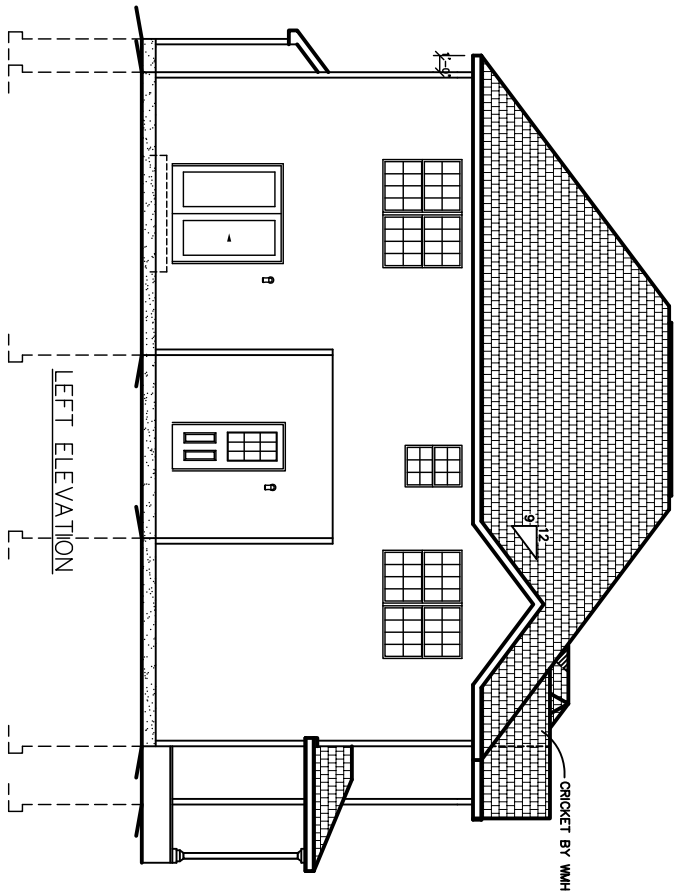

LEFT ELEVATION

SEE STANDARD NOTES & DETAILS DWG #8

USE GROUP: SINGLE FAMILY	BUILDER: TRANSPARENTLY GREEN 4 HIDDEN MEADOW DRIVE WARWICK, NY 10990	HOMEOWNER: SPEC	SERIAL No. 08162	PE / RA	THIRD PARTY INSPECTION AGENCY
CONST. TYPE: 5B	SITE: 28 HOYT ROAD WARWICK, NY 10990		PRODUCTION No.		
DESIGNER: V.GIORGIO	COLONIAL CTM-R ELEVATIONS		REVISION	DATE	
DATE: 09/08/08					
SCALE: 1/8" = 1'-0"			CHECK	DATE	
PAGE: 1	 Westchester Modular Homes Inc 30 Reagans Mill Road, Wingdale, New York, 12594 Tel (845)832-9400 Fax (845)832-6698		V.GIORGIO	10/12/07	